


2 EXTERIOR VIEW OF SOUTH FACADE
SCALE:

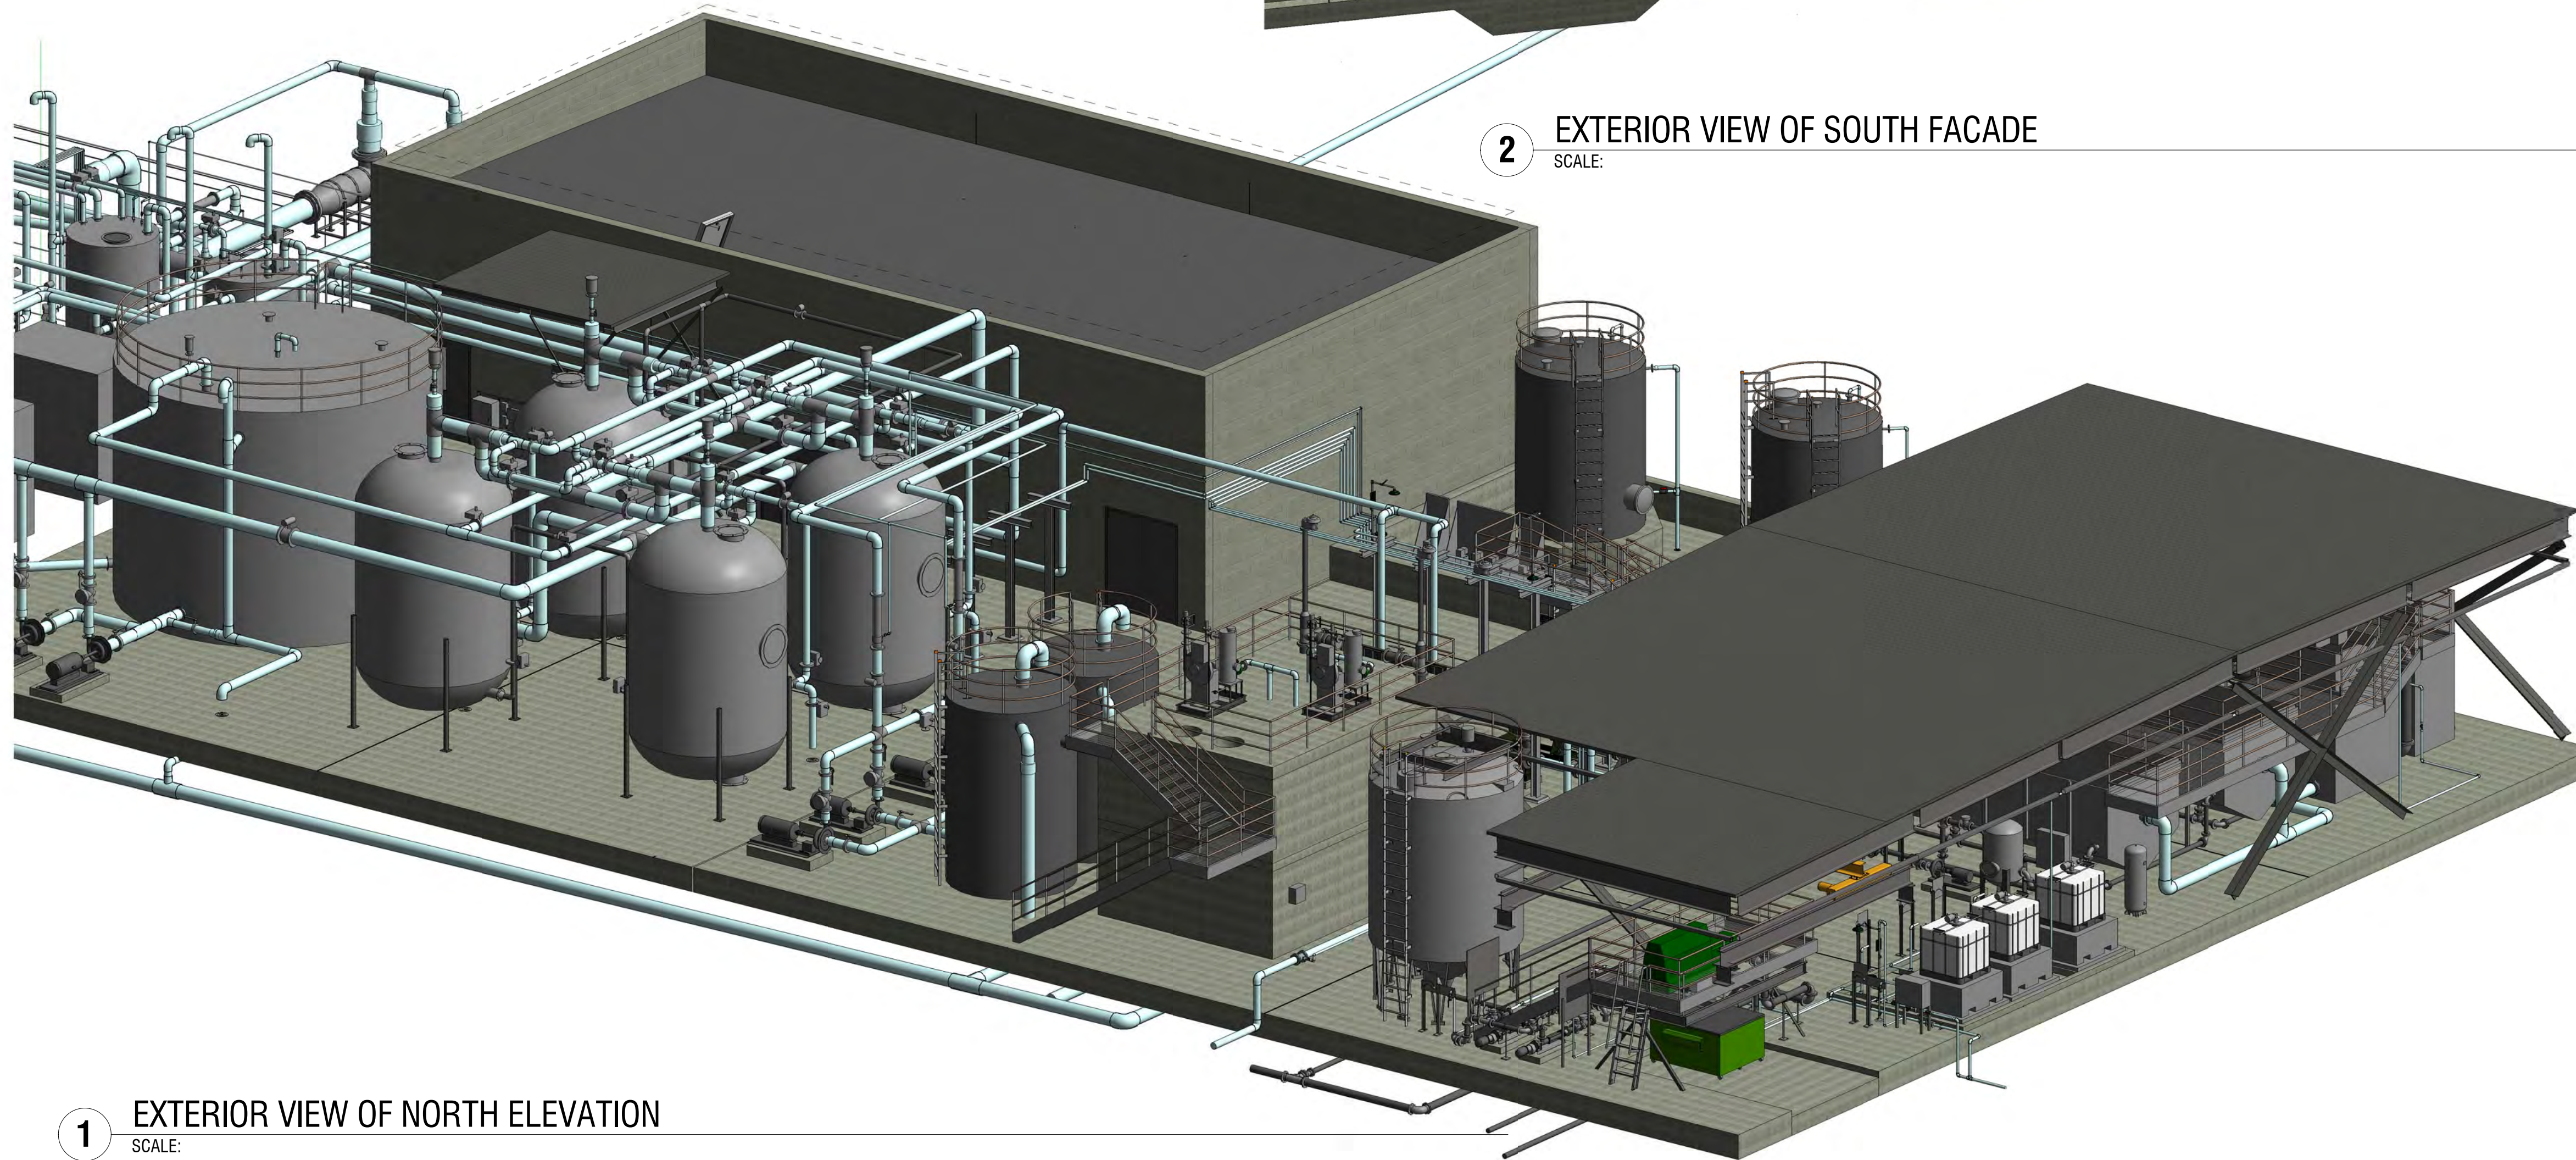

1 EXTERIOR VIEW OF NORTH ELEVATION
SCALE:

NO.	DATE	BY

REVISIONS
Revision Description

CONTRACT NO. 8427C.66	PROJECT TITLE MEL LEONG TREATMENT PLANT INDUSTRIAL WASTEWATER AND RECYCLED WATER UPGRADES	SHEET TITLE 3D MODEL
---------------------------------	---	--------------------------------

APPROVED: DEPUTY AIRPORT DIRECTOR	CHECKED BY: G. ROBLEY
APPROVED: PRINCIPAL ARCHITECT/ENGINEER	DATE: 07/24/17
DESIGNED BY: K. SABETA-BAK	SCALE: AS NOTED
DRAWN BY: A. HARM	SIZE: ARCH-D
SHEET NUMBER	



30A13.1